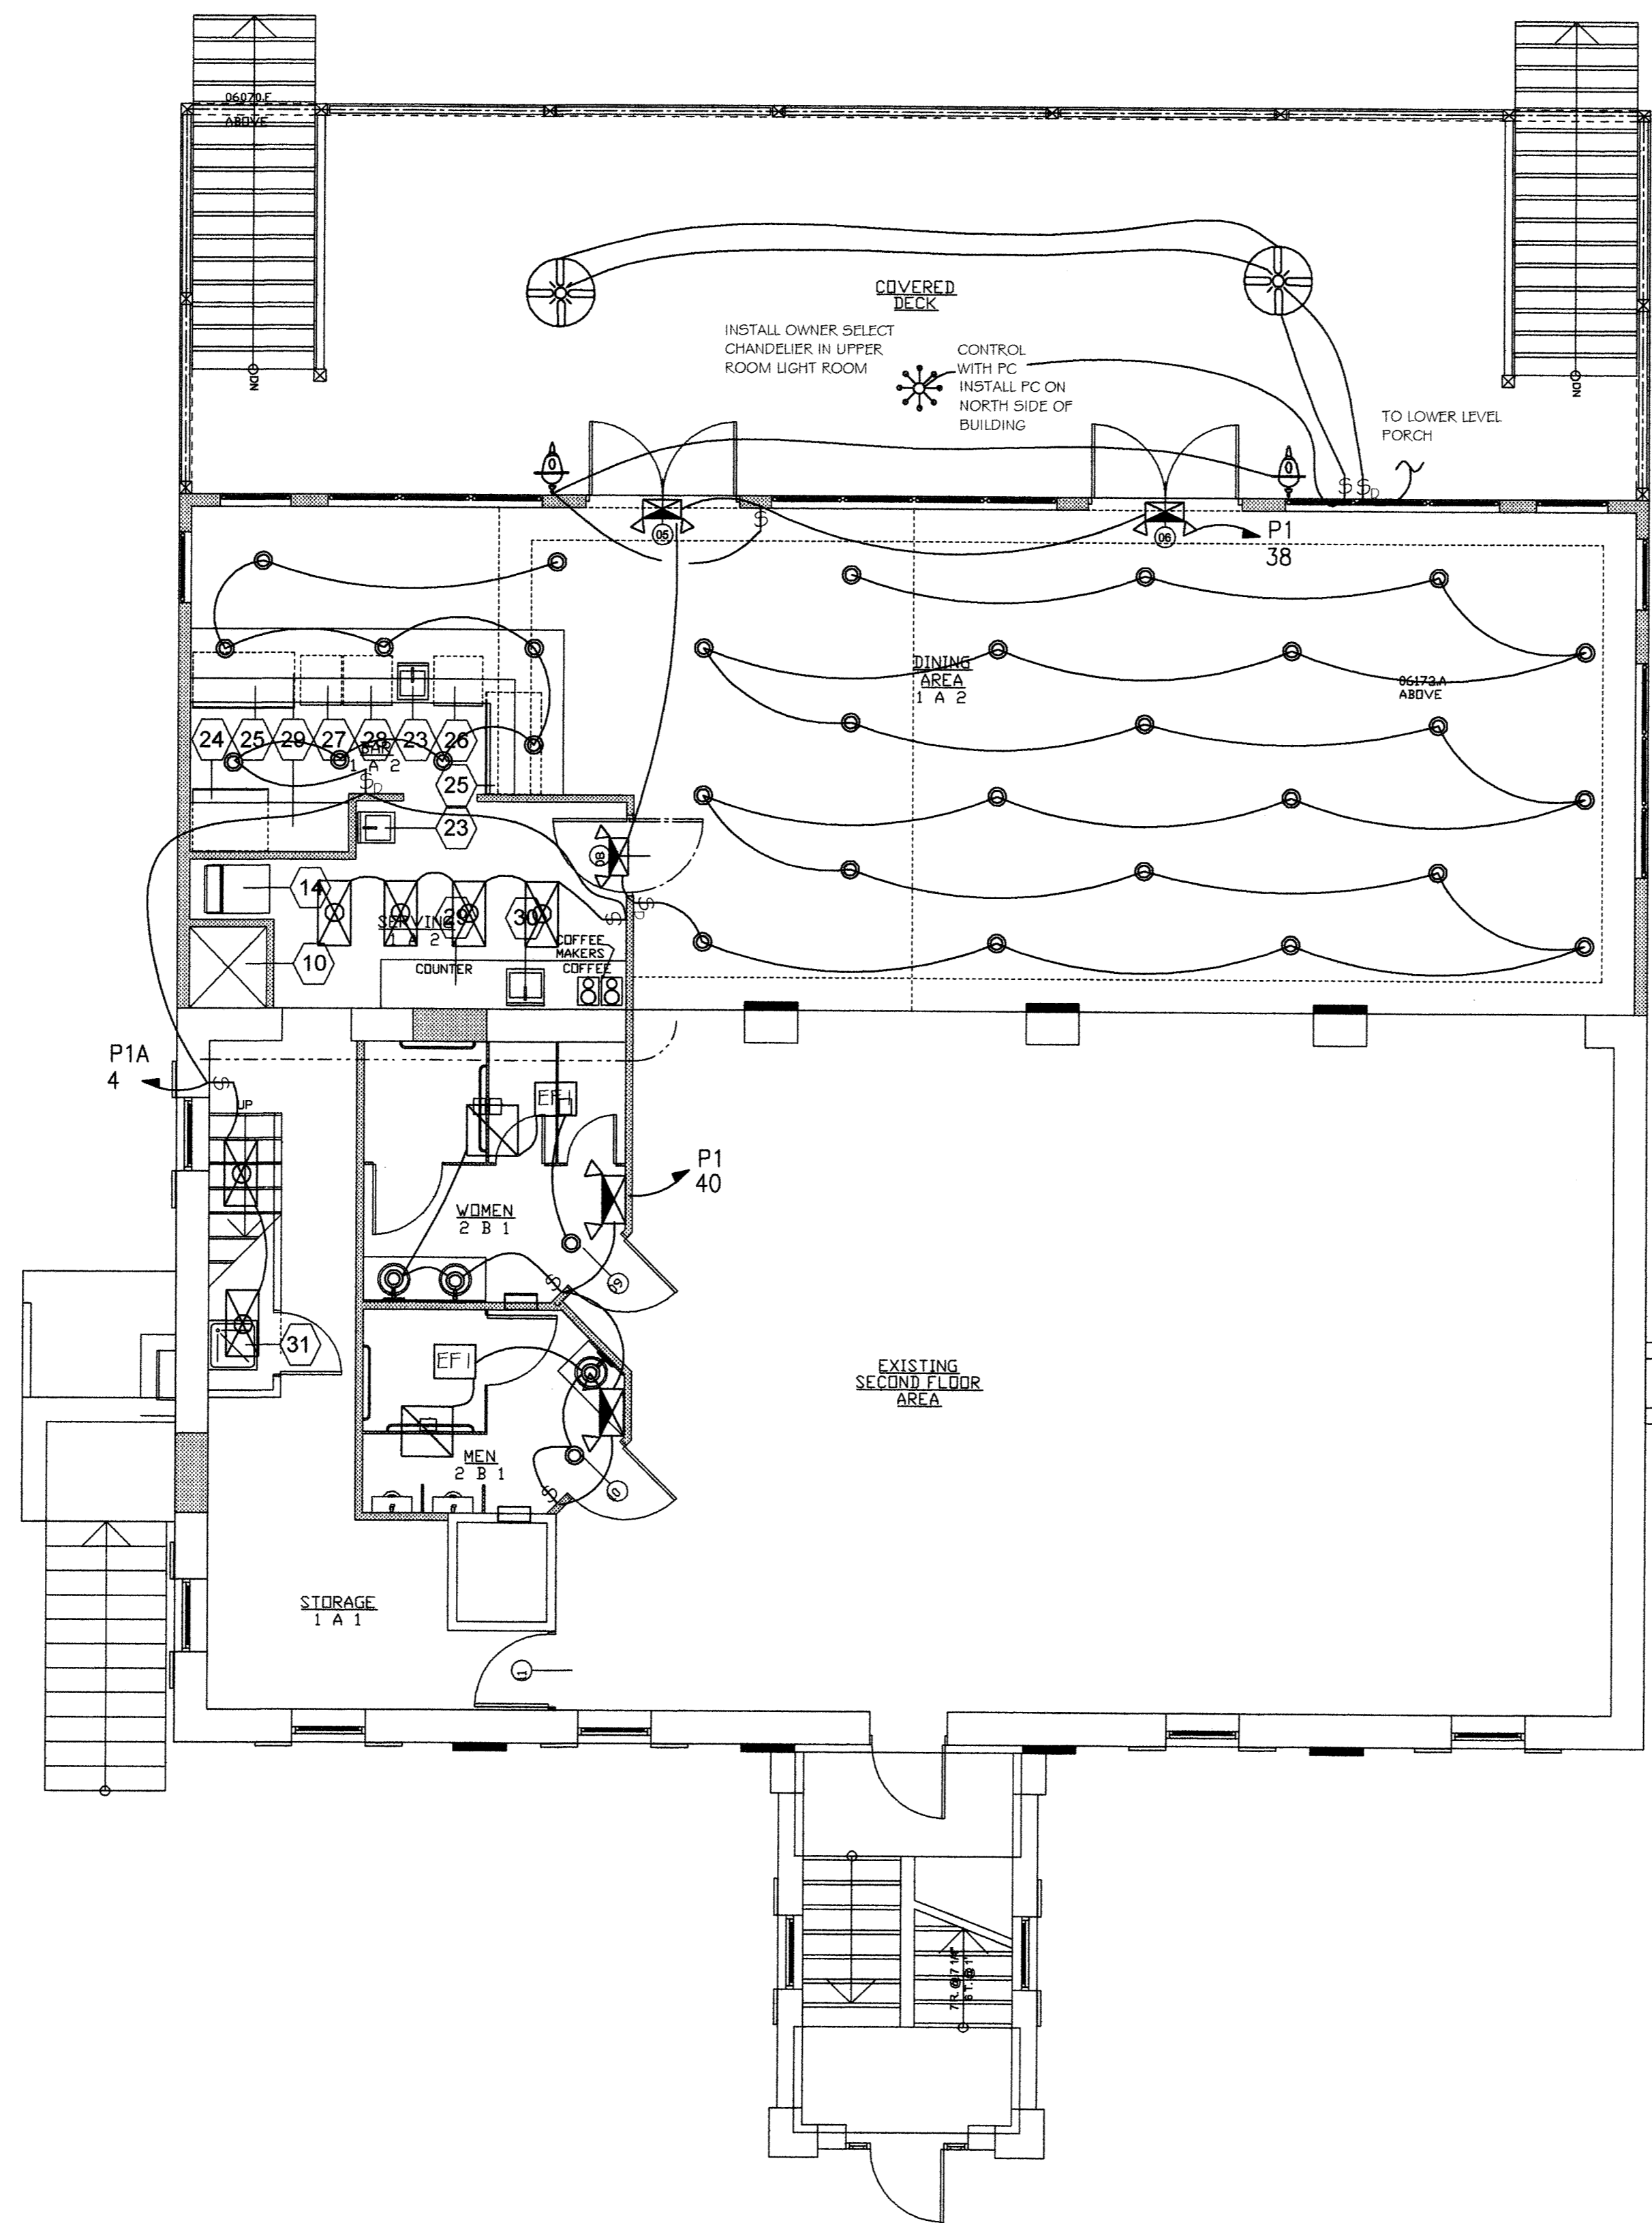


1 2 3 4 5 6 7 8 9 10 11 12 13 14 15 16

P
O
Z
M
L
K
J
I
H
G
F
E
D
C
B
A



 
 

 


 





UPPER LEVEL LIGHTING PLAN

SCALE: 3/16" = 1'-0"

MATERIALS KEYNOTES

LIGHT FIXTURE SCHEDULE

- 
 2x4 FLUORESCENT GRID FIXTURE
LITHONIA 2SPG332FWASL120GEB
(3) 32W T8 LAMPS
120VAC, 1.0A
- 
 2x2 FLUORESCENT GRID FIXTURE
LITHONIA 2SPGU231FWASL120GEB
(2) U31W T8 LAMPS
120VAC, 0.7A
- 
 2x4 SURFACE FLUORESCENT
SIMKAR SN990332B11
(3) 32W T8 LAMPS
120VAC, 1.0A
- 
 HANGING CHANDELIER TYPE FIXTURE
SPEC'D BY OWNER
SIZED FOR 250W LAMP
120VAC, 2.1A
- 
 INCANDESCENT DOWN LIGHT
PATHWAY IC-7 WITH OR775 TRIM
60W A-19 INCANDESCENT LAMP
120VAC, 0.5A
- 
 WALL MOUNT BATHROOM FIXTURE
SELECTION BY OWNER
75 WATT ALLOWANCE, \$75 ALLOWANCE
120VAC, 0.75A
- 
 FLUORESCENT EXTERIOR GRADE WALL LANTERN
SEAGULL 89287PBLE-746
(1) U26W FLUORESCENT
120VAC, 0.25A
- 
 WALL PACK COMPACT
SIMKAR HHHSOL11
(1) 50W HPS E-17 LAMP
120VAC, 0.5A
- 
 EMERGENCY LIGHT UNIT
PATHWAY AR-2-H
(2) 5W HALOGEN BULBS
120VAC, 0.05A
- 
 LED EXIT SIGN W/ EMERGENCY LIGHTS
PATHWAY PLEP12X2R UNIVERSAL
120 VAC, 20W, 0.17A
- 
 CEILING PADDLE FAN/LIGHT
W/LIGHT FIXTURE
DAYTON 1VP23 W/6NP32 LIGHT KIT
SIZED FOR 160W
120VAC, 1.4A
LIGHT KIT AND FAN SWITCHED SEPARATELY
LIGHT CONTROLLED BY DIMMER SWITCH
- 
 FLUORESCENT UTILITY STRIP - PENDANT
MIDWEST F22232E120
(2) 32W T8
120VAC, 0.5A

REVISIONS/SUBMISSIONS	Date

LEWIS ENGINEERING ASSOCIATES, INC
MECHANICAL and ELECTRICAL ENGINEERS
28841 RIVERWATCH DRIVE, MECHANICSVILLE, MD 20659
PHONE (301) 884-3370 FAX (301) 884-2654 EMAIL lewiseng.net

Patuxent Architects

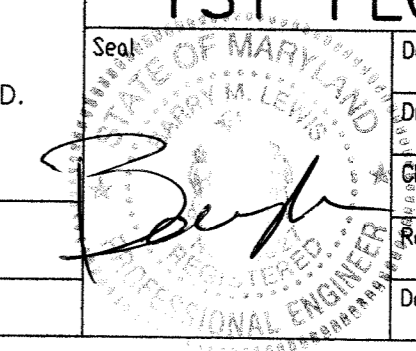
P.O. Box 421 www.patuxentarchitects.com TEL 410-257-9298
Prince Frederick, Maryland 20678 FAX 410-535-4127

Solomons Yacht Club
Solomons Island, MD

Drawing Title
1ST FLOOR LIGHTING PLAN

ENGINEER'S CERTIFICATION STATEMENT

I CERTIFY THAT THESE DOCUMENTS WERE PREPARED OR APPROVED BY ME, AND THAT I AM A DULY LICENSED ENGINEER UNDER THE LAWS OF THE STATE OF MARYLAND. LICENSE NO. 16927, EXPIRATION DATE MAY 12, 2010.



Designed BL	Project No.
Drawn NL	Scale 3/16" = 1'-0"
Checked BL	Drawing No. E-1
Reviewed BL	Date MAR. 24, 2009

1 2 3 4 5 6 7 8 9 10 11 12 13 14 15 16