


1 2 3 4 5 6 7 8 9 10 11 12 13 14 15 16

P  
O  
Z  
M  
F  
K  
C  
H  
I  
G  
F  
E  
D  
C  
B  
A

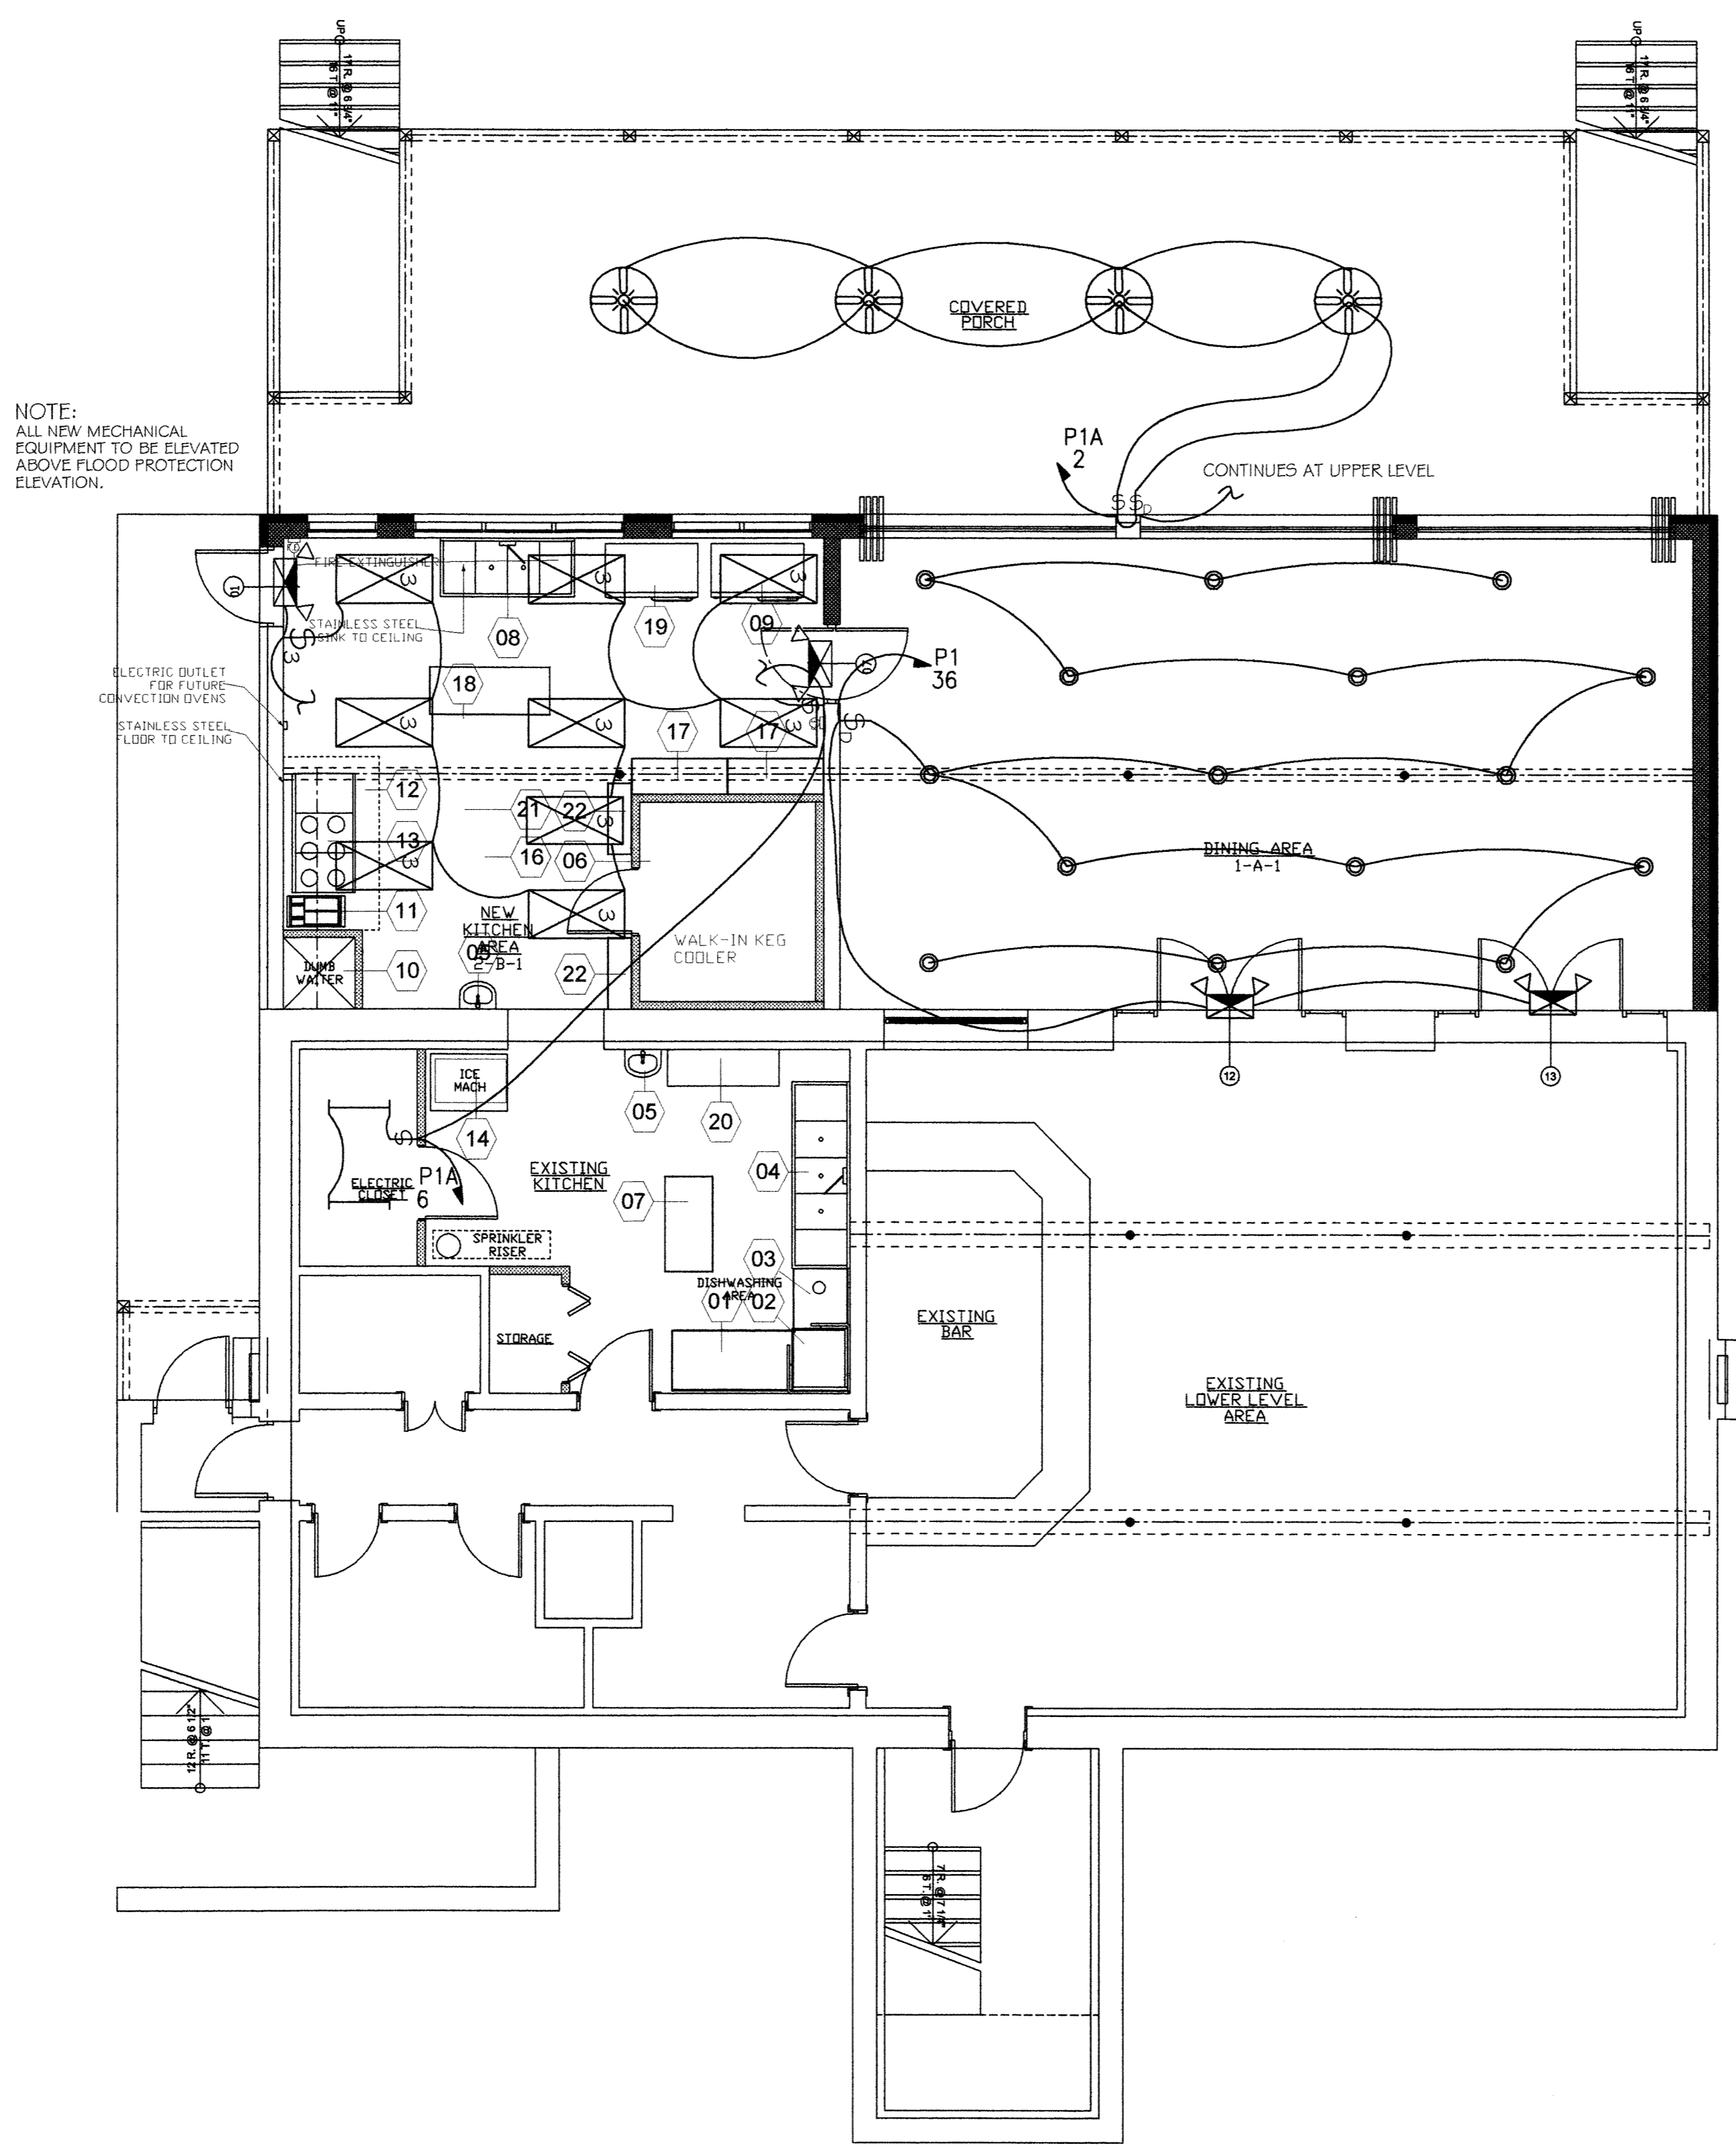

NOTE:  
ALL NEW MECHANICAL  
EQUIPMENT TO BE ELEVATED  
ABOVE FLOOD PROTECTION  
ELEVATION.

NOTE:  
ALL NEW MECHANICAL  
EQUIPMENT TO BE ELEVATED  
ABOVE FLOOD PROTECTION  
ELEVATION.

MATERIALS KEYNOTES

**LOWER LEVEL LIGHTING PLAN**

SCALE: 3/16" = 1'-0"

**ENGINEER'S CERTIFICATION STATEMENT**

I CERTIFY THAT THESE DOCUMENTS WERE PREPARED OR APPROVED BY ME, AND THAT I AM A DULY LICENSED ENGINEER UNDER THE LAWS OF THE STATE OF MARYLAND. LICENSE NO. 16927, EXPIRATION DATE MAY 12, 2010.

**LEWIS ENGINEERING ASSOCIATES, INC**  
MECHANICAL and ELECTRICAL ENGINEERS  
28841 RIVERWATCH DRIVE, MECHANICSVILLE, MD 20659  
PHONE (301) 884-3370 FAX (301) 884-2654 EMAIL lewiseng.net

**Patuxent Architects**

P.O. Box 421 www.patuxentarchitects.com TEL 410-357-9298  
Prince Frederick, Maryland 20676 FAX 410-535-4127

**Solomons Yacht Club**  
Solomons Island, MD

Drawing Title  
**LOWER LEVEL LIGHTING PLAN**

Designed BL	Project No.
Drawn NL	Scale 3/16" = 1'-0"
Checked BL	Drawing No. <b>E-3</b>
Reviewed BL	3 of 5
Date MAR. 24, 2009	

1 2 3 4 5 6 7 8 9 10 11 12 13 14 15 16