


1 2 3 4 5 6 7 8 9 10 11 12 13 14 15 16

P
O
Z
M
F
K
C
U
I
I
G
F
E
D
C
B
A

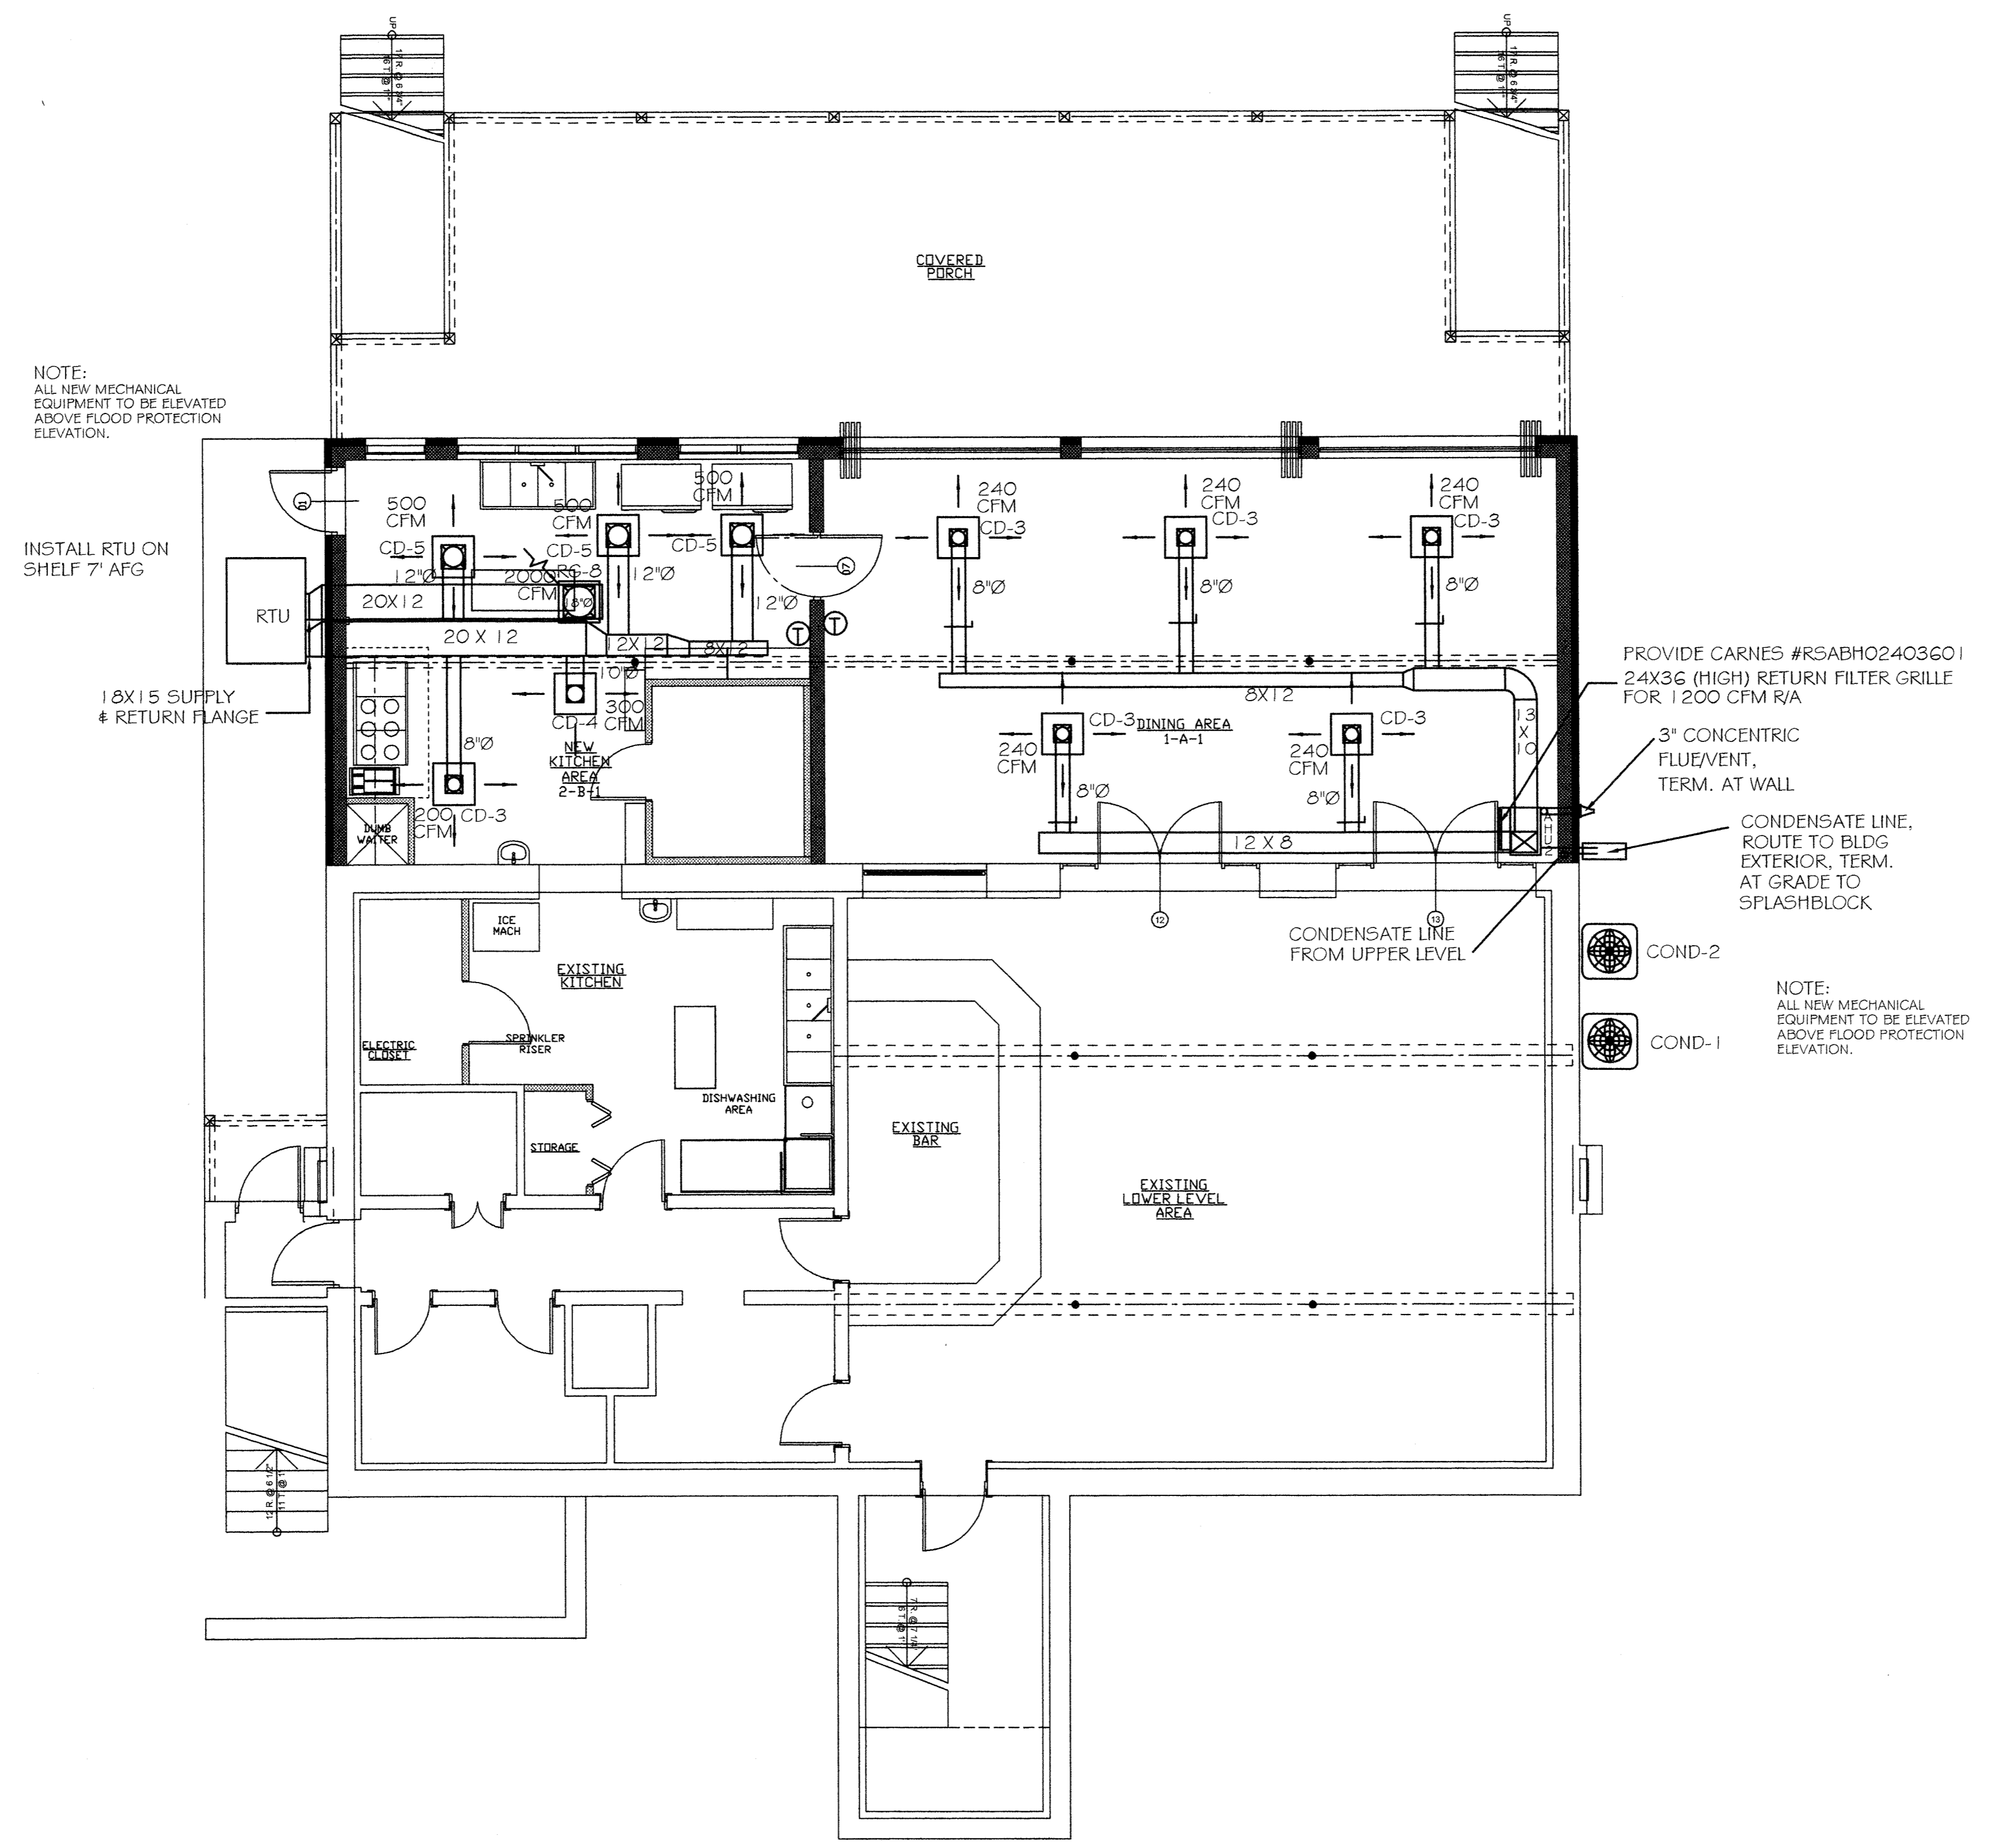

NOTE:
ALL NEW MECHANICAL
EQUIPMENT TO BE ELEVATED
ABOVE FLOOD PROTECTION
ELEVATION.

INSTALL RTU ON
SHELF 7' AFG

18X15 SUPPLY
& RETURN FLANGE

PROVIDE CARNES #RSABH02403G01
24X36 (HIGH) RETURN FILTER GRILLE
FOR 1200 CFM R/A

3" CONCENTRIC
FLUE/VENT,
TERM. AT WALL

CONDENSATE LINE,
ROUTE TO BLDG
EXTERIOR, TERM.
AT GRADE TO
SPLASHBLOCK

COND-2

COND-1

NOTE:
ALL NEW MECHANICAL
EQUIPMENT TO BE ELEVATED
ABOVE FLOOD PROTECTION
ELEVATION.

MATERIALS KEYNOTES

LOWER LEVEL MECHANICAL PLAN
SCALE: 3/16" = 1'-0"

ENGINEER'S CERTIFICATION STATEMENT

I CERTIFY THAT THESE DOCUMENTS WERE PREPARED OR APPROVED BY ME, AND THAT I AM A DULY LICENSED ENGINEER UNDER THE LAWS OF THE STATE OF MARYLAND. LICENSE NO. 16927, EXPIRATION DATE MAY 12, 2010.

REVISIONS/SUBMISSIONS
LEWIS ENGINEERING ASSOCIATES, INC
MECHANICAL and ELECTRICAL ENGINEERS
28841 RIVERWATCH DRIVE, MECHANICSVILLE, MD 20659
PHONE (301) 884-3370 FAX (301) 884-2654 EMAIL lewiseng.net

Patuxent Architects
P.O. Box 421 Prince Frederick, Maryland 20676 www.patuxentarchitects.com TEL 410-257-9298 FAX 410-535-4127

Solomons Yacht Club
Solomons Island, MD

Drawing Title
LOWER LEVEL MECHANICAL PLAN

Designed BL	Project No.
Drawn NL	Scale 3/16" = 1'-0"
Checked BL	Drawing No. M-2
Reviewed BL	Date MAR. 24, 2009
2 of 3	

1 2 3 4 5 6 7 8 9 10 11 12 13 14 15 16