


1 2 3 4 5 6 7 8 9 10 11 12 13 14 15 16

P
O
Z
K
L
M
N
O
P
Q
R
S
T
U
V
W
X
Y
Z
A
B
C
D
E
F
G
H
I
J
K
L
M
N
O
P
Q
R
S
T
U
V
W
X
Y
Z
A

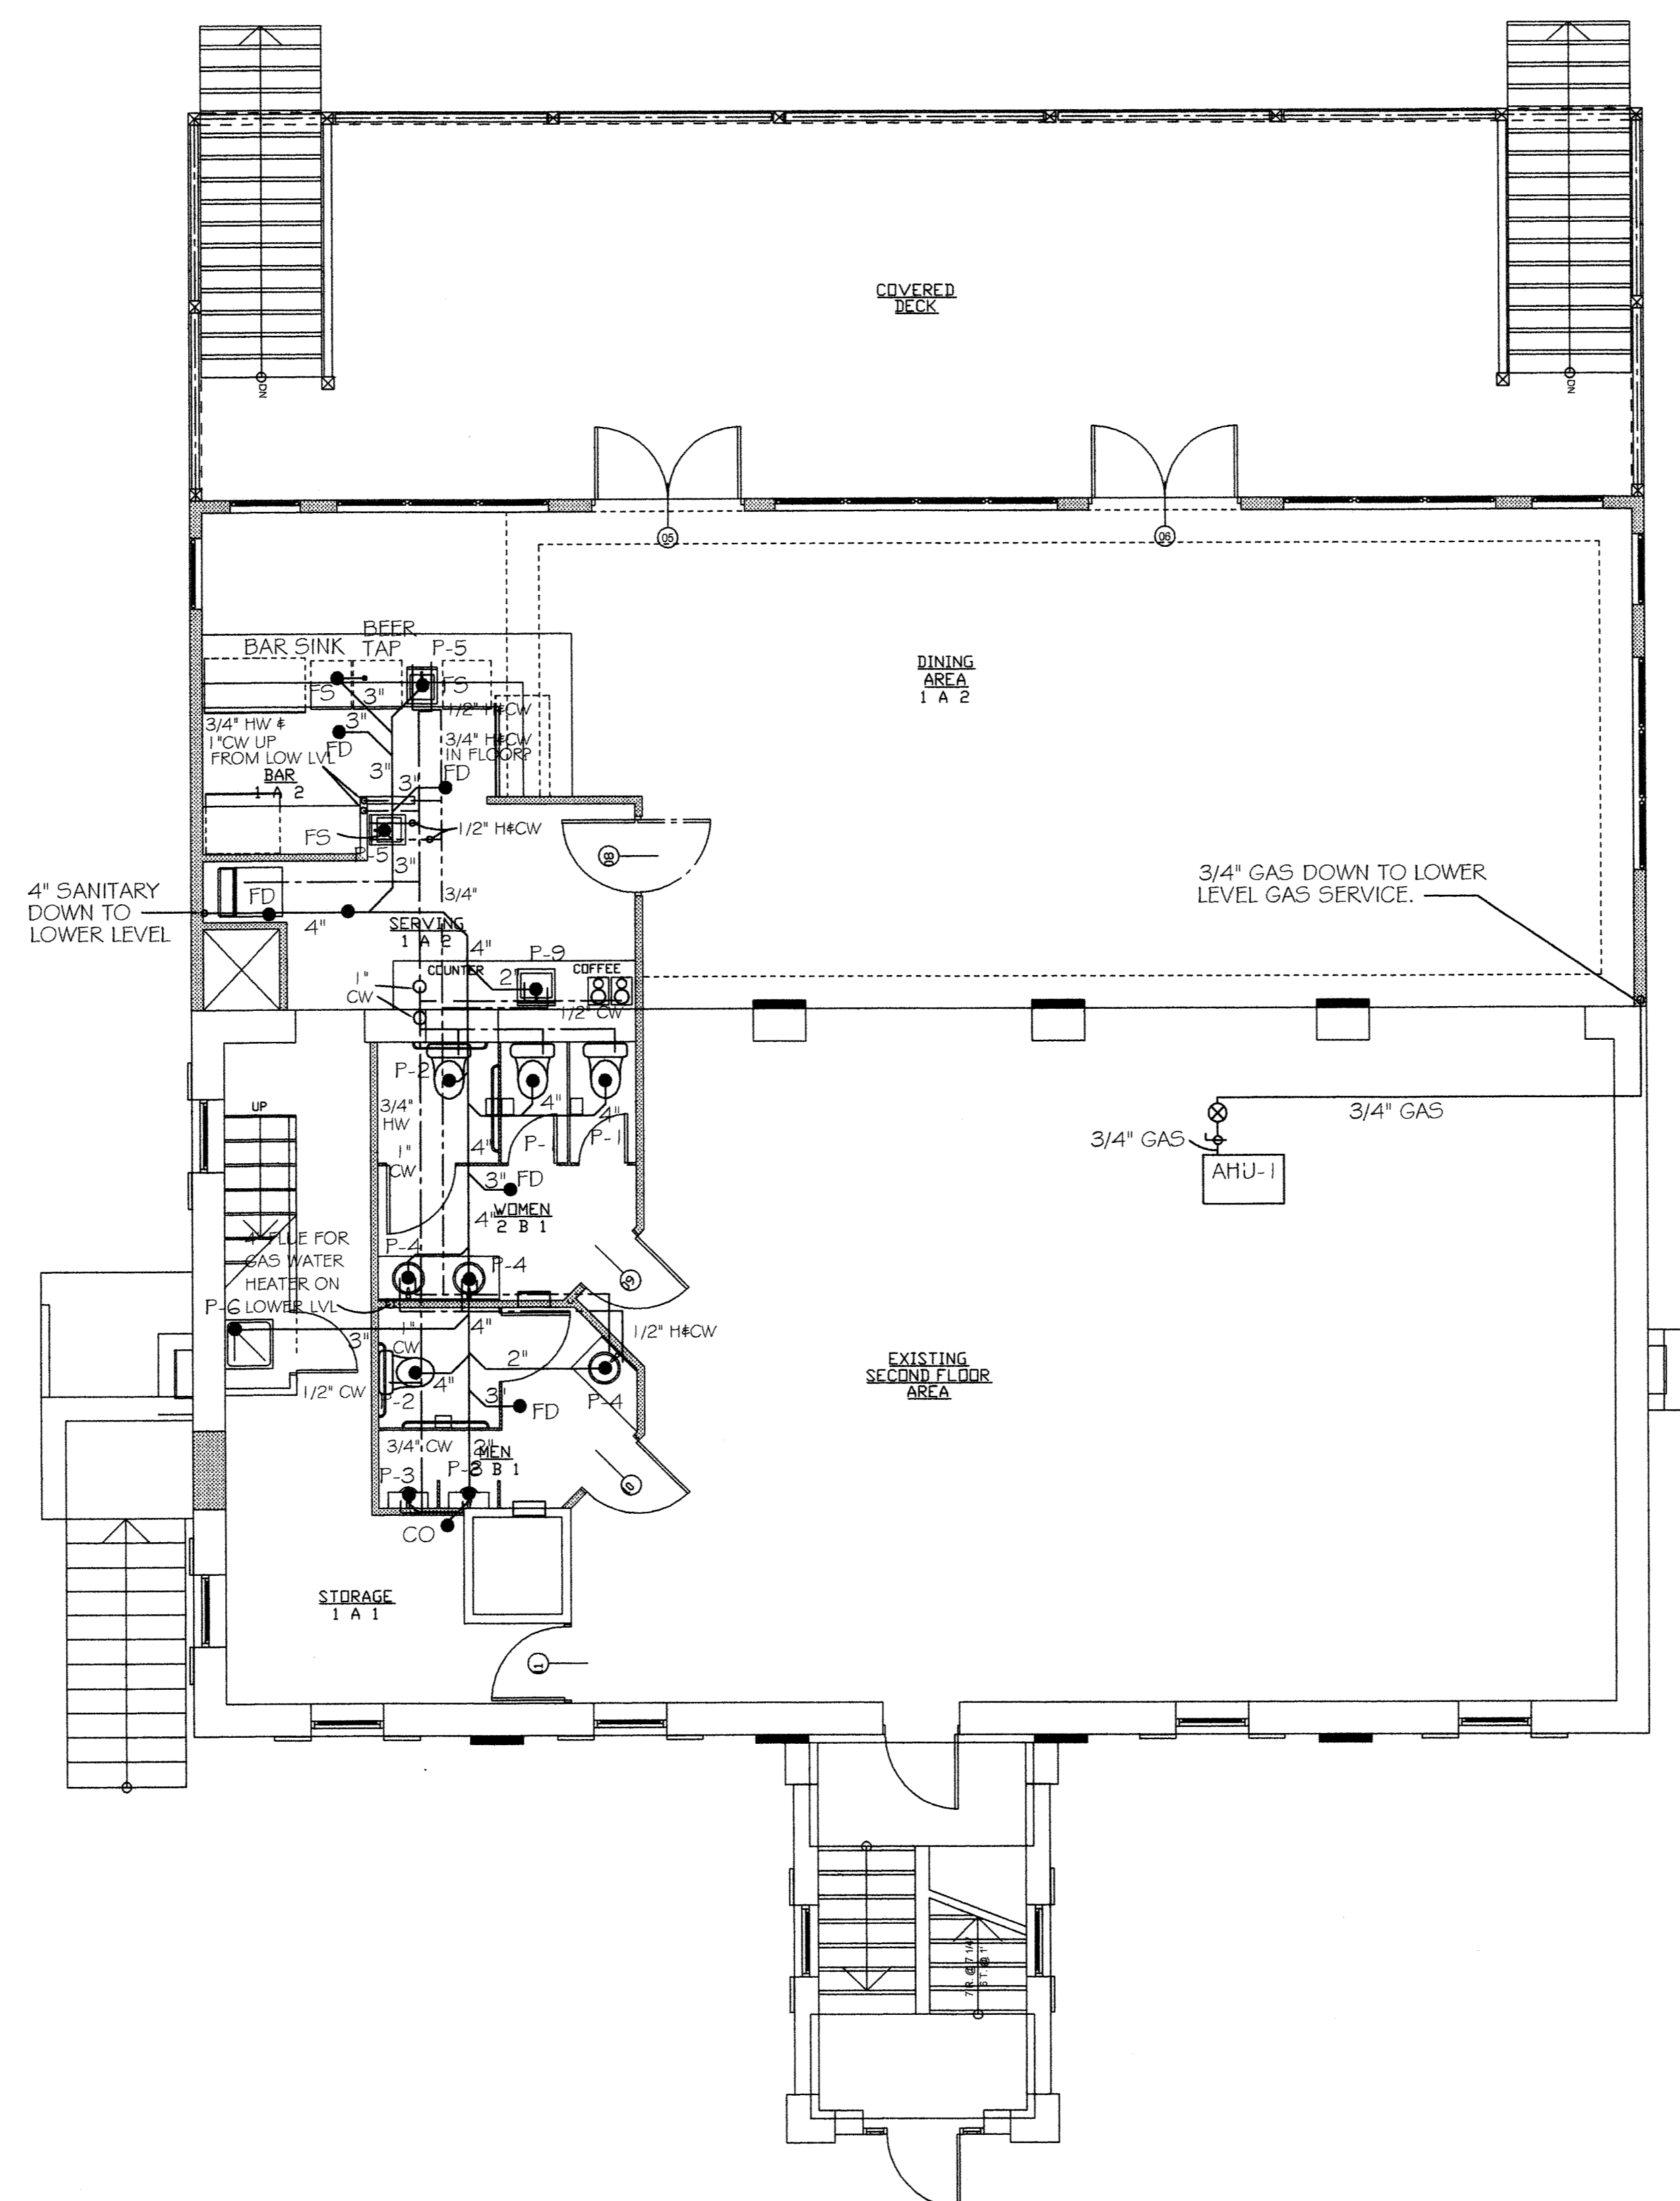

UPPER LEVEL PLUMBING PLAN

SCALE: 3/16" = 1'-0"

MATERIALS KEYNOTES

REVISIONS/SUBMISSIONS Date

LEWIS ENGINEERING ASSOCIATES, INC
MECHANICAL and ELECTRICAL ENGINEERS
 28841 RIVERWATCH DRIVE, MECHANICSVILLE, MD 20659
 PHONE (301) 884-3370 FAX (301) 884-2654 EMAIL lewiseng.net

Patuxent Architects

P.O. Box 421 www.patuxentarchitects.com TEL 410-257-9298
 Prince Frederick, Maryland 20676 FAX 410-535-4127

Solomons Yacht Club
 Solomons Island, MD

ENGINEER'S CERTIFICATION STATEMENT

I CERTIFY THAT THESE DOCUMENTS WERE PREPARED OR APPROVED BY ME, AND THAT I AM A DULY LICENSED ENGINEER UNDER THE LAWS OF THE STATE OF MARYLAND. LICENSE NO. 16927, EXPIRATION DATE MAY 12, 2010.

Drawing Title UPPER LEVEL PLUMBING PLAN		Project No.
Designed BL	Scale 3/16" = 1'-0"	Drawing No. P-1 1 of 3
Drawn BL		
Checked BL		
Reviewed BL		
Date MAR. 24, 2009		

1 2 3 4 5 6 7 8 9 10 11 12 13 14 15 16