


1 2 3 4 5 6 7 8 9 10 11 12 13 14 15 16

P
O
Z
M
F
K
C
I
I
G
T
E
D
C
B
A

NOTE:
ALL NEW MECHANICAL
EQUIPMENT TO BE ELEVATED
ABOVE FLOOD PROTECTION
ELEVATION.

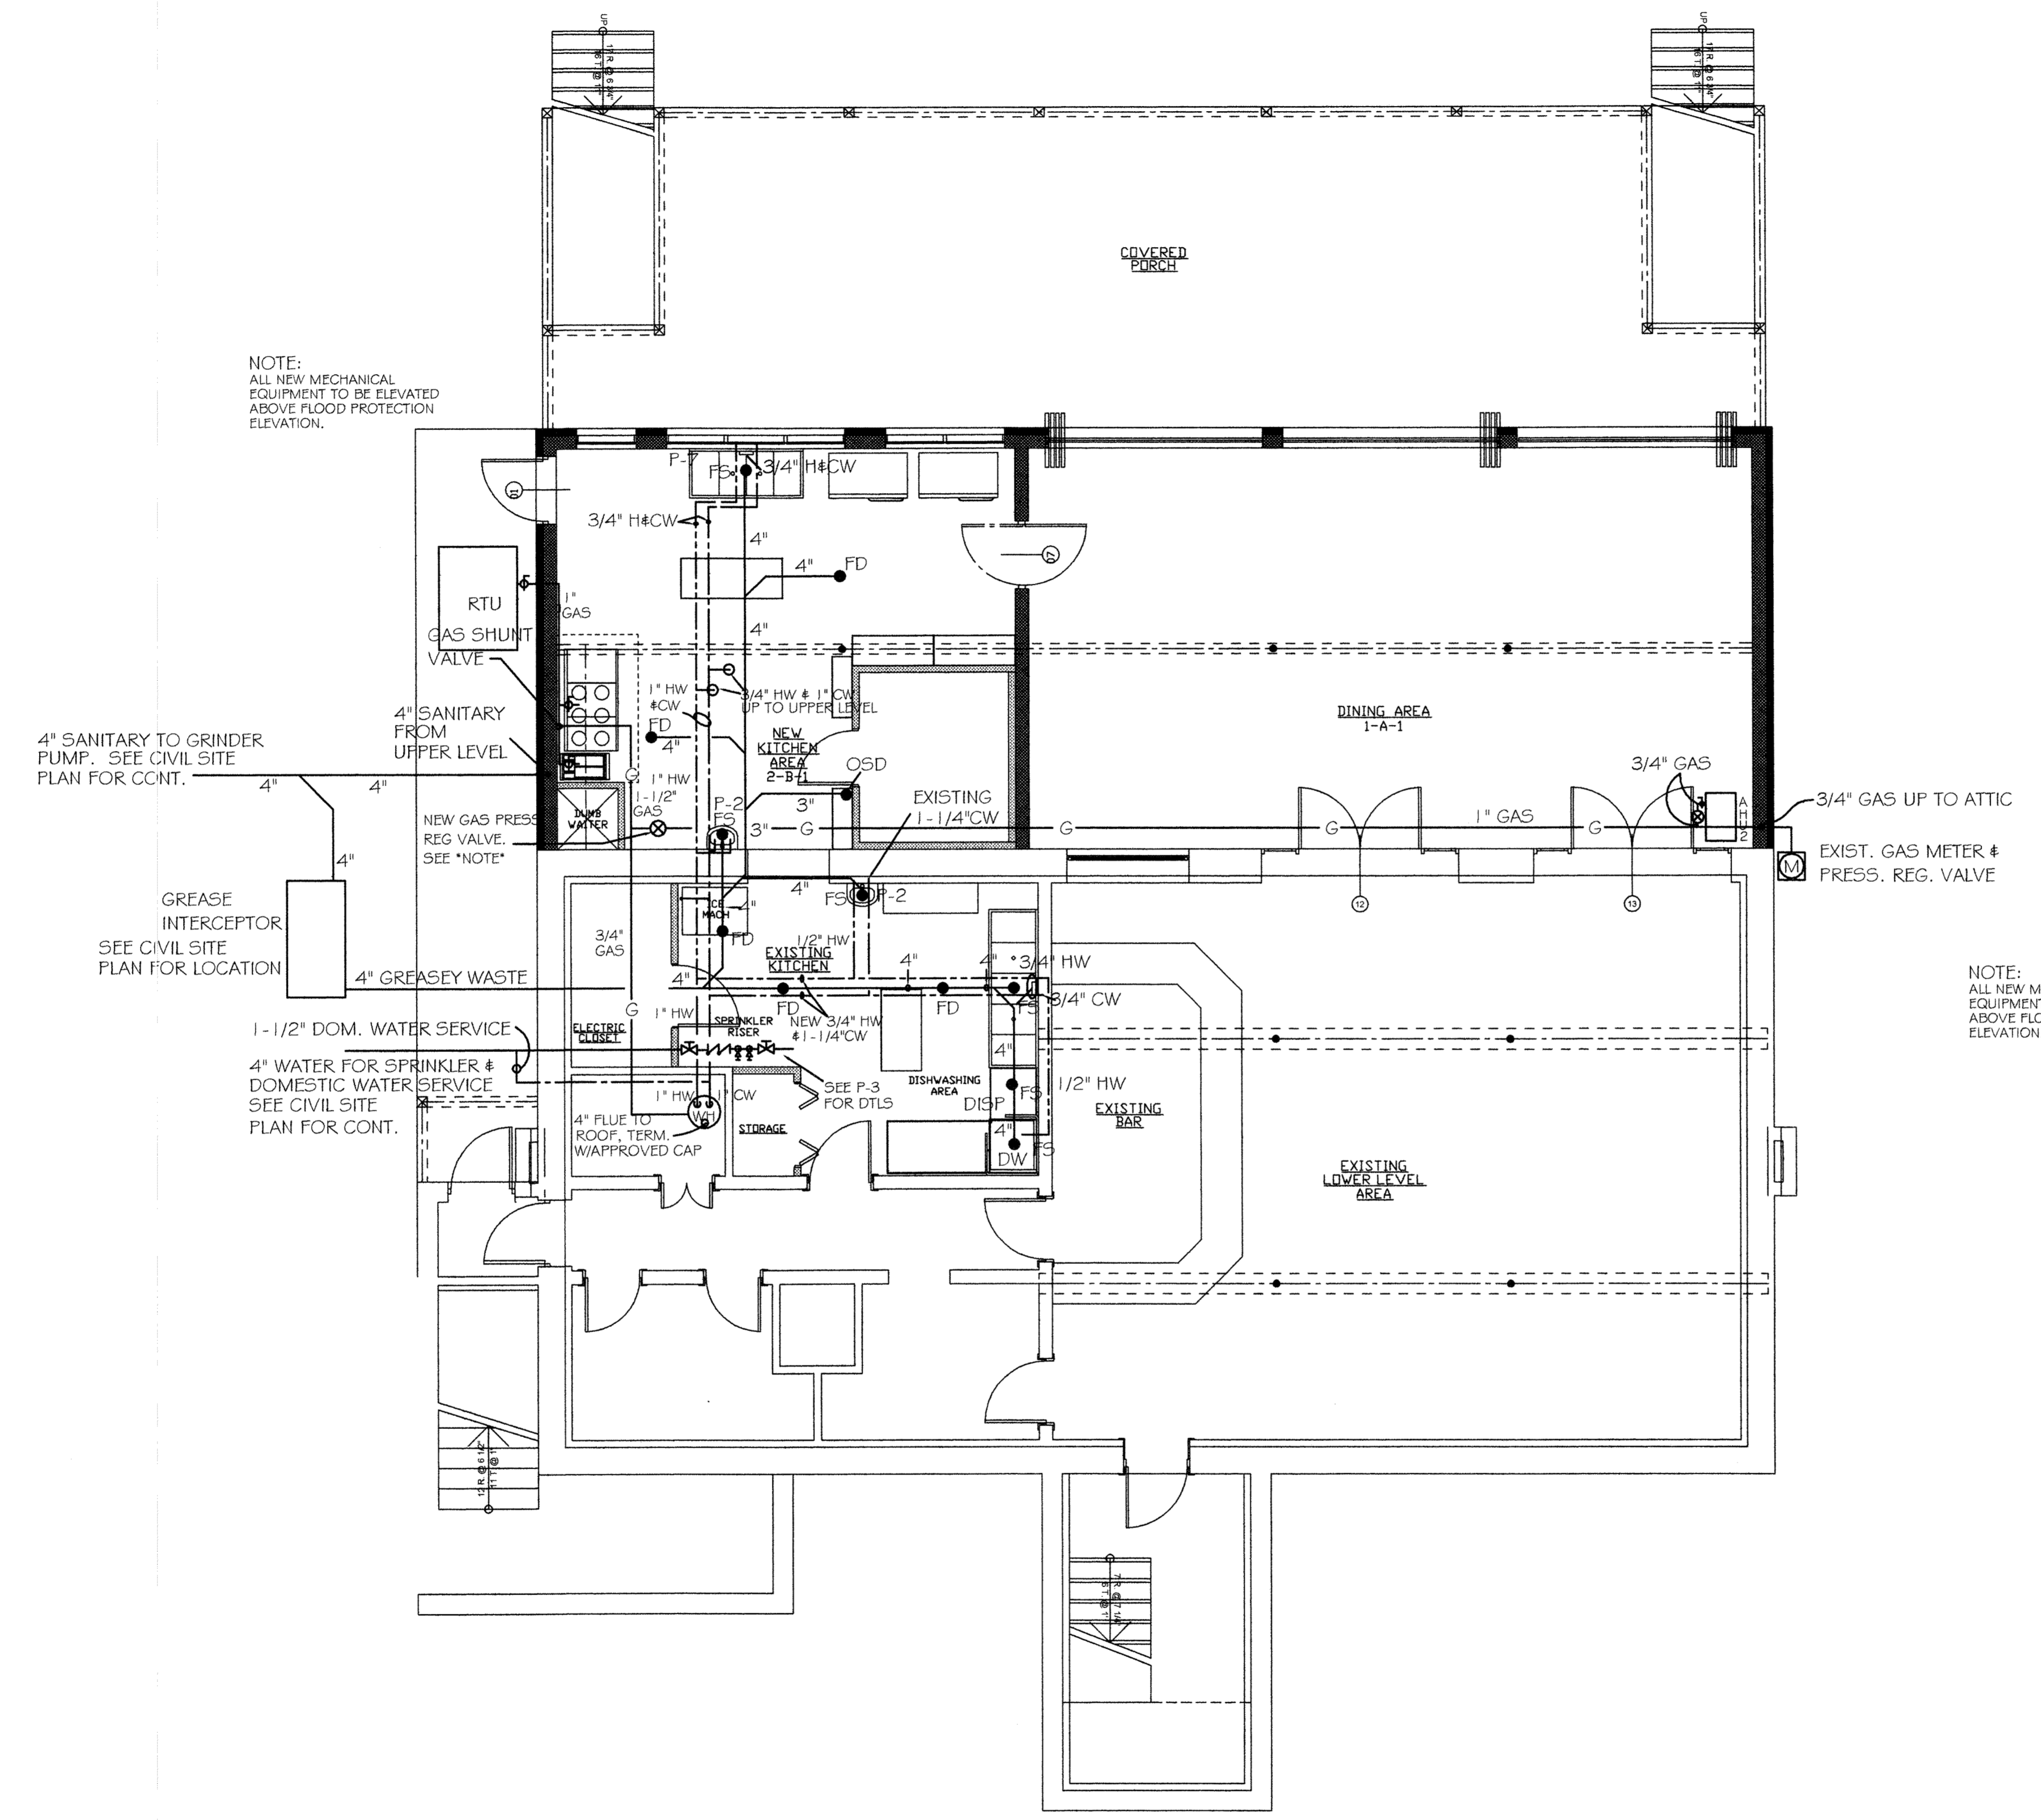

NOTE:
ALL NEW MECHANICAL
EQUIPMENT TO BE ELEVATED
ABOVE FLOOD PROTECTION
ELEVATION.

MATERIALS KEYNOTES

LOWER LEVEL PLUMBING PLAN

SCALE: 3/16" = 1'-0"

ENGINEER'S CERTIFICATION STATEMENT

I CERTIFY THAT THESE DOCUMENTS WERE PREPARED OR APPROVED BY ME, AND THAT I AM A DULY LICENSED ENGINEER UNDER THE LAWS OF THE STATE OF MARYLAND. LICENSE NO. 16927, EXPIRATION DATE MAY 12, 2010.

Drawing Title		LOWER LEVEL PLUMBING PLAN	
Designed	BL	Project No.	
Drawn	NL	Scale	3/16" = 1'-0"
Checked	BL	Drawing No.	P-2
Reviewed	BL	Date	MAR 24, 2009
		2 of 3	

REVISIONS/SUBMISSIONS

REVISIONS/SUBMISSIONS	Date

LEWIS ENGINEERING ASSOCIATES, INC
MECHANICAL and ELECTRICAL ENGINEERS
 28841 RIVERWATCH DRIVE, MECHANICSVILLE, MD 20659
 PHONE (301) 884-3370 FAX (301) 884-2654 EMAIL lewiseng.net

Patuxent Architects

P.O. Box 421 Prince Frederick, Maryland 20676 TEL 410-257-9296 FAX 410-535-4127

Solomons Yacht Club
Solomons Island, MD

1 2 3 4 5 6 7 8 9 10 11 12 13 14 15 16